

Vetster's Workspace

230-240 W Broughton Street,Savannah,
Georgia, 31401, United States



Vidhanshi Soni
<https://vidhanshi25soni.wixsite.com/vidhanshisoni>
Clark Hall, Savannah, Georgia
Job Date: 1st March, 2024

Vetster's Workspace
230-240 W Broughton Street, Savannah,
Georgia, 31401, United States

Revision

Checked by: Vidhanshi Soni

Cover Page

G001

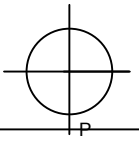
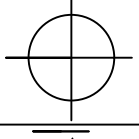
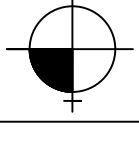
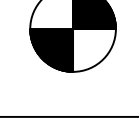
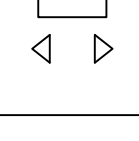
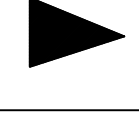
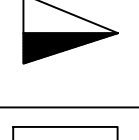
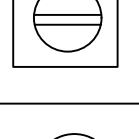
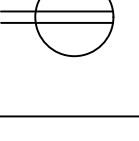
Index

Content	PG. NO.
Cover Sheet	G001
Floor Plan (2nd Floor)	A101
Floor Plan (3rd Floor)	A102
RCP (2nd Floor)	A103
RCP (3rd Floor)	A104
Furniture Plan (2nd Floor)	I101
Furniture Plan (3rd Floor)	I102
Floor Finish Plan (2nd Floor)	I103
Floor Finish Plan (3rd Floor)	I104
Large Scale Power and Data Plan	I401
Large Scale Furniture Plan	I401
Wall Elevations	I201
Wall Elevations	I202






Code Information

Occupany Type as per IBC 2018- B (Business)
Project Square Footage-
2nd Floor- 7800 SQ FT
3rd Floor- 7900 SQ FT
Total- 15700 SQ FT
Occupancy Load Factor- 150 Gross
2nd Floor- 52
3rd Floor- 53
Total- 105
Codes Used in this project:
International Building Codes (2018)
Life Safety Codes (2018)

Abbreviations

LVP: Luxury Vinyl Plank
RS: Resistant Sheet
T: Tile
CPT: Carpet
AFF: Above Finished Floor
 Ceiling mounted Pendant
 Ceiling mounted light
 Wall mounted light
 Exit Light
 Emergency Light
 Wall Mounted Data outlet
 Wall Mounted Data Outlet and Telephone Outlet
 Floor Duplex Outlet
 Duplex Outlet

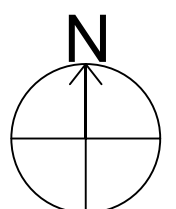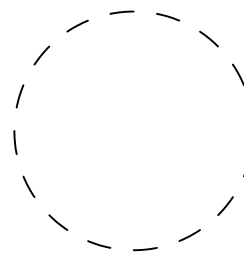 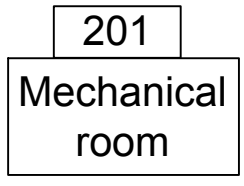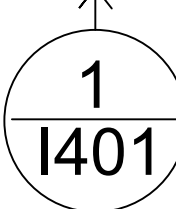Symbols

 North Arrow
 ADA Turn Circle, 5ft Diameter
 Clear Floor Space 30" x 48"
 Room Number Room Name
 Ceiling Type Ceiling Height
 Interior Elevations
 Detail



Vidhanshi Soni
<https://vidhanshi25soni.wixsite.com/vidhanshisoni>
Clark Hall, Savannah, Georgia
Job Date: 1st March, 2024

Vetster's Workspace

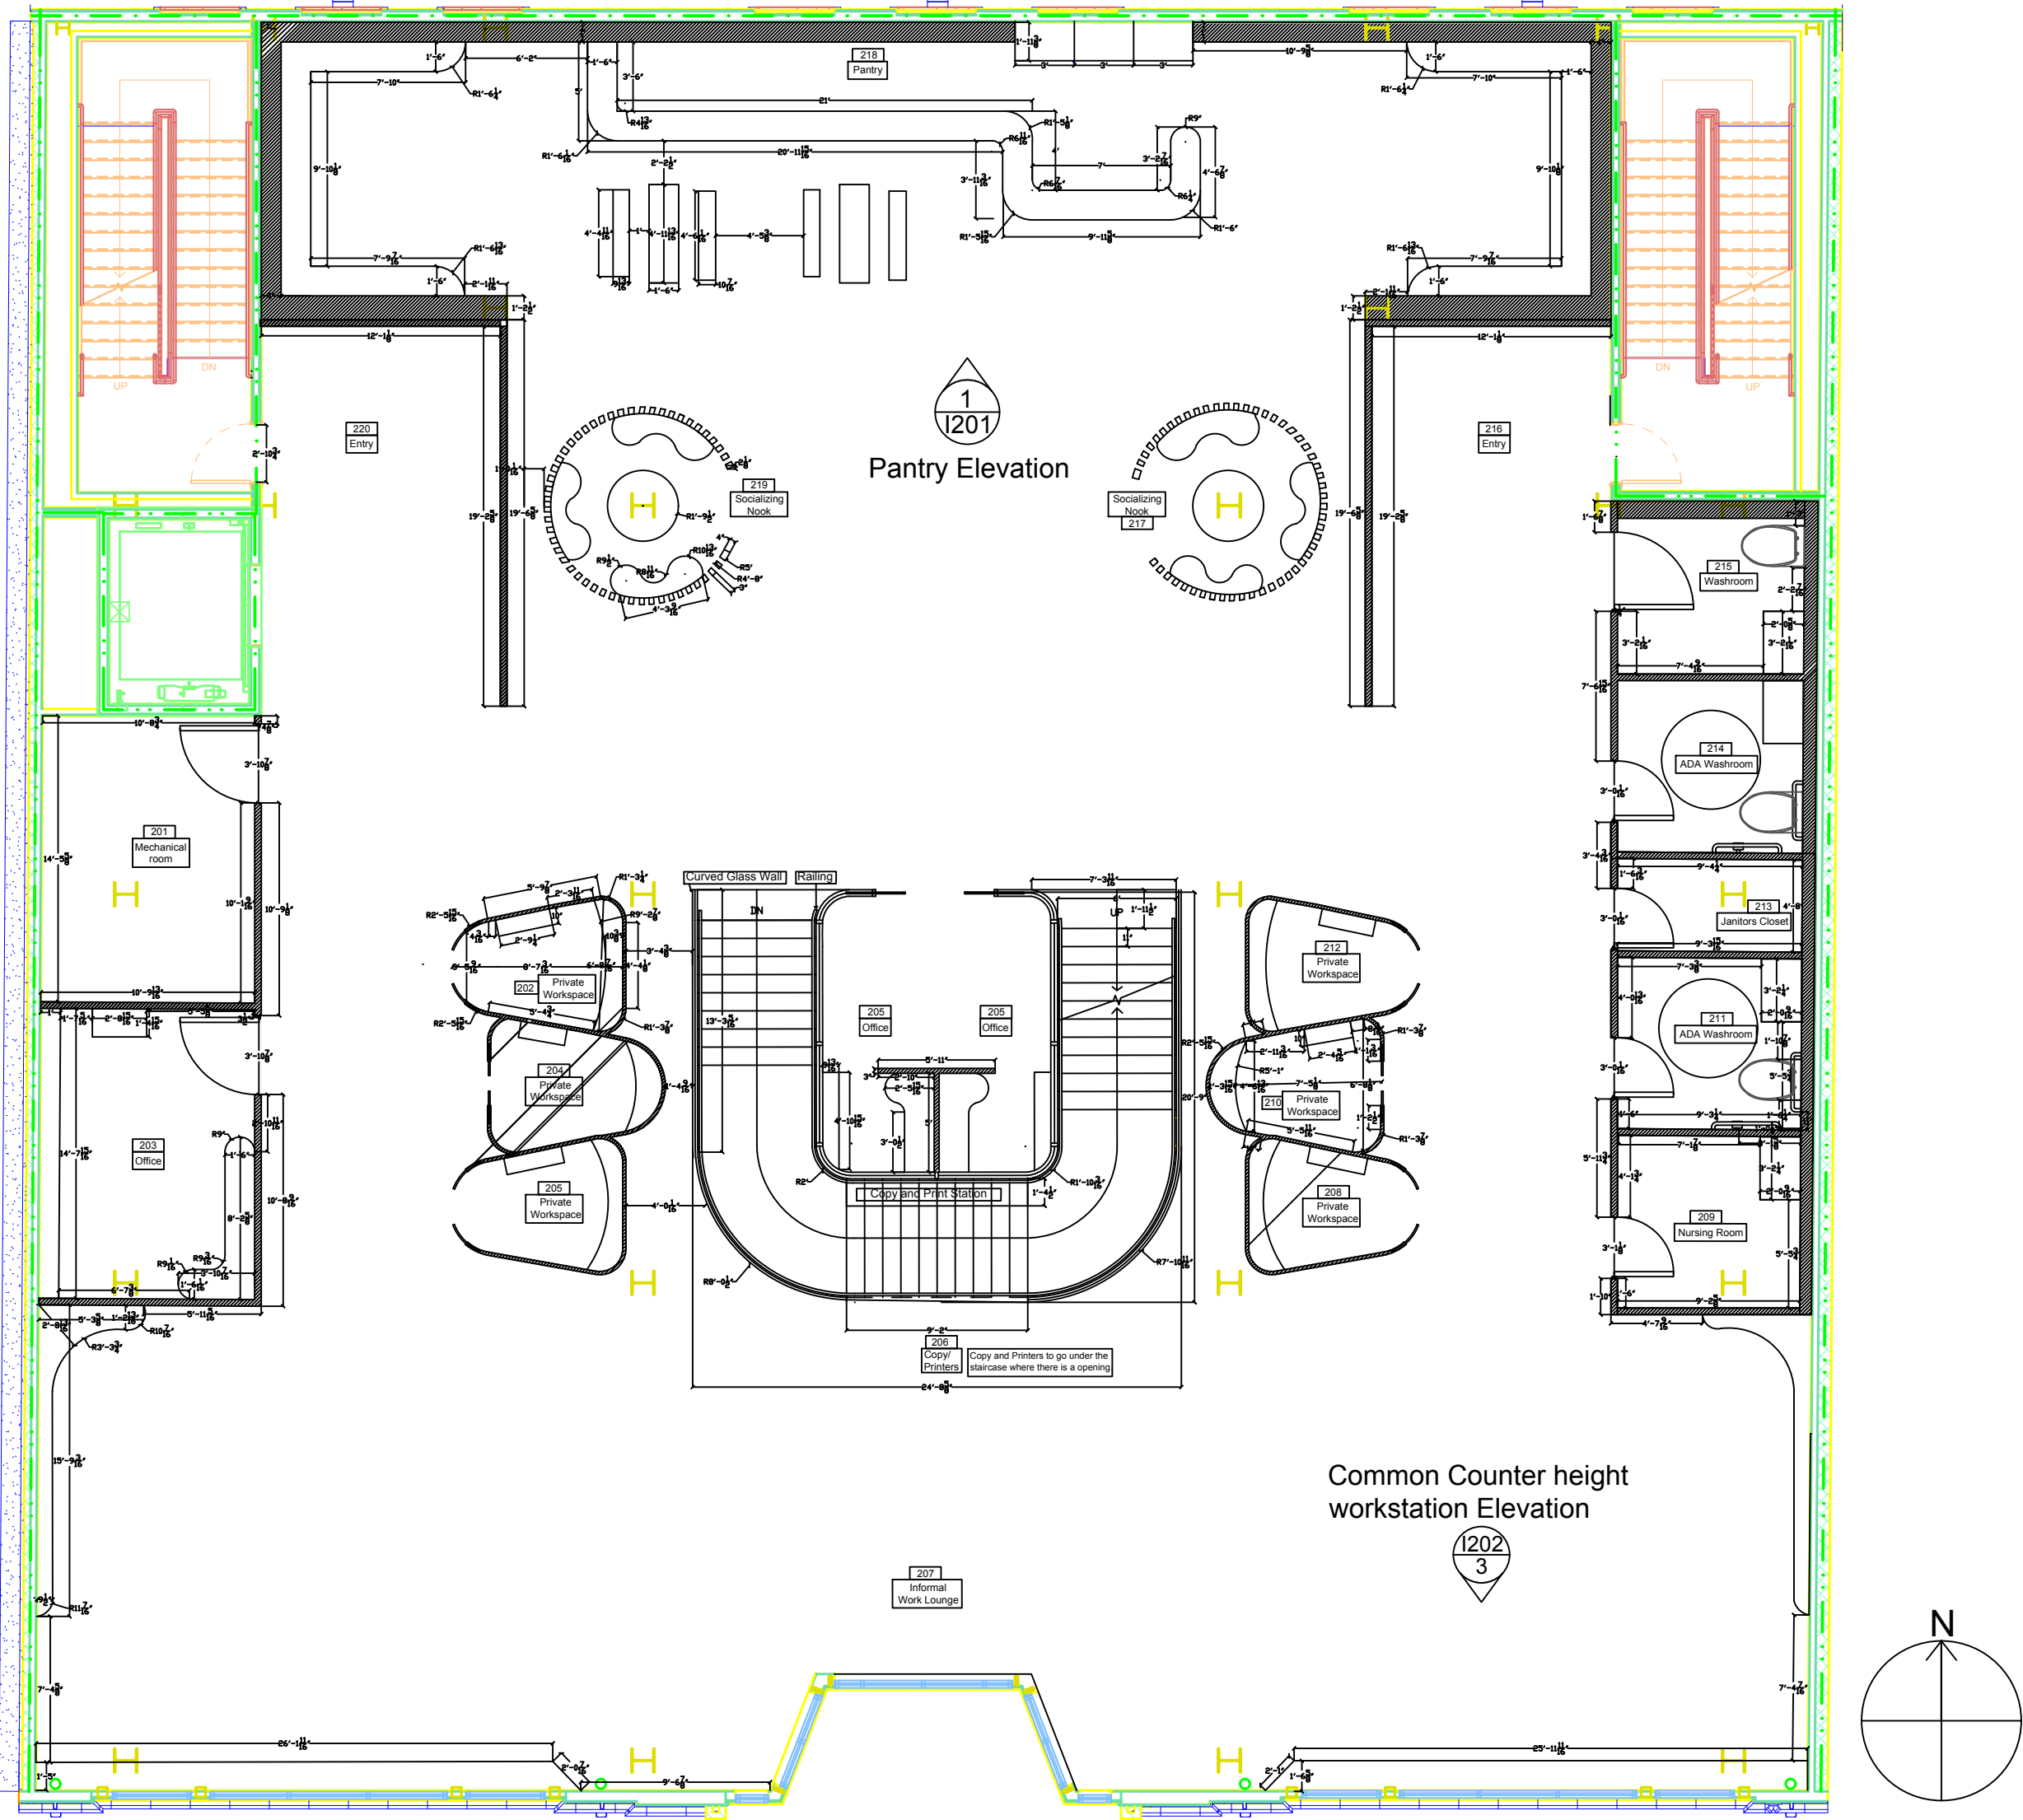
230-240 W Broughton Street, Savannah,
Georgia, 31401, United States

Revision

Checked by: Vidhanshi Soni


Floor Plan- Second Floor

A101



1. Second Floor Plan

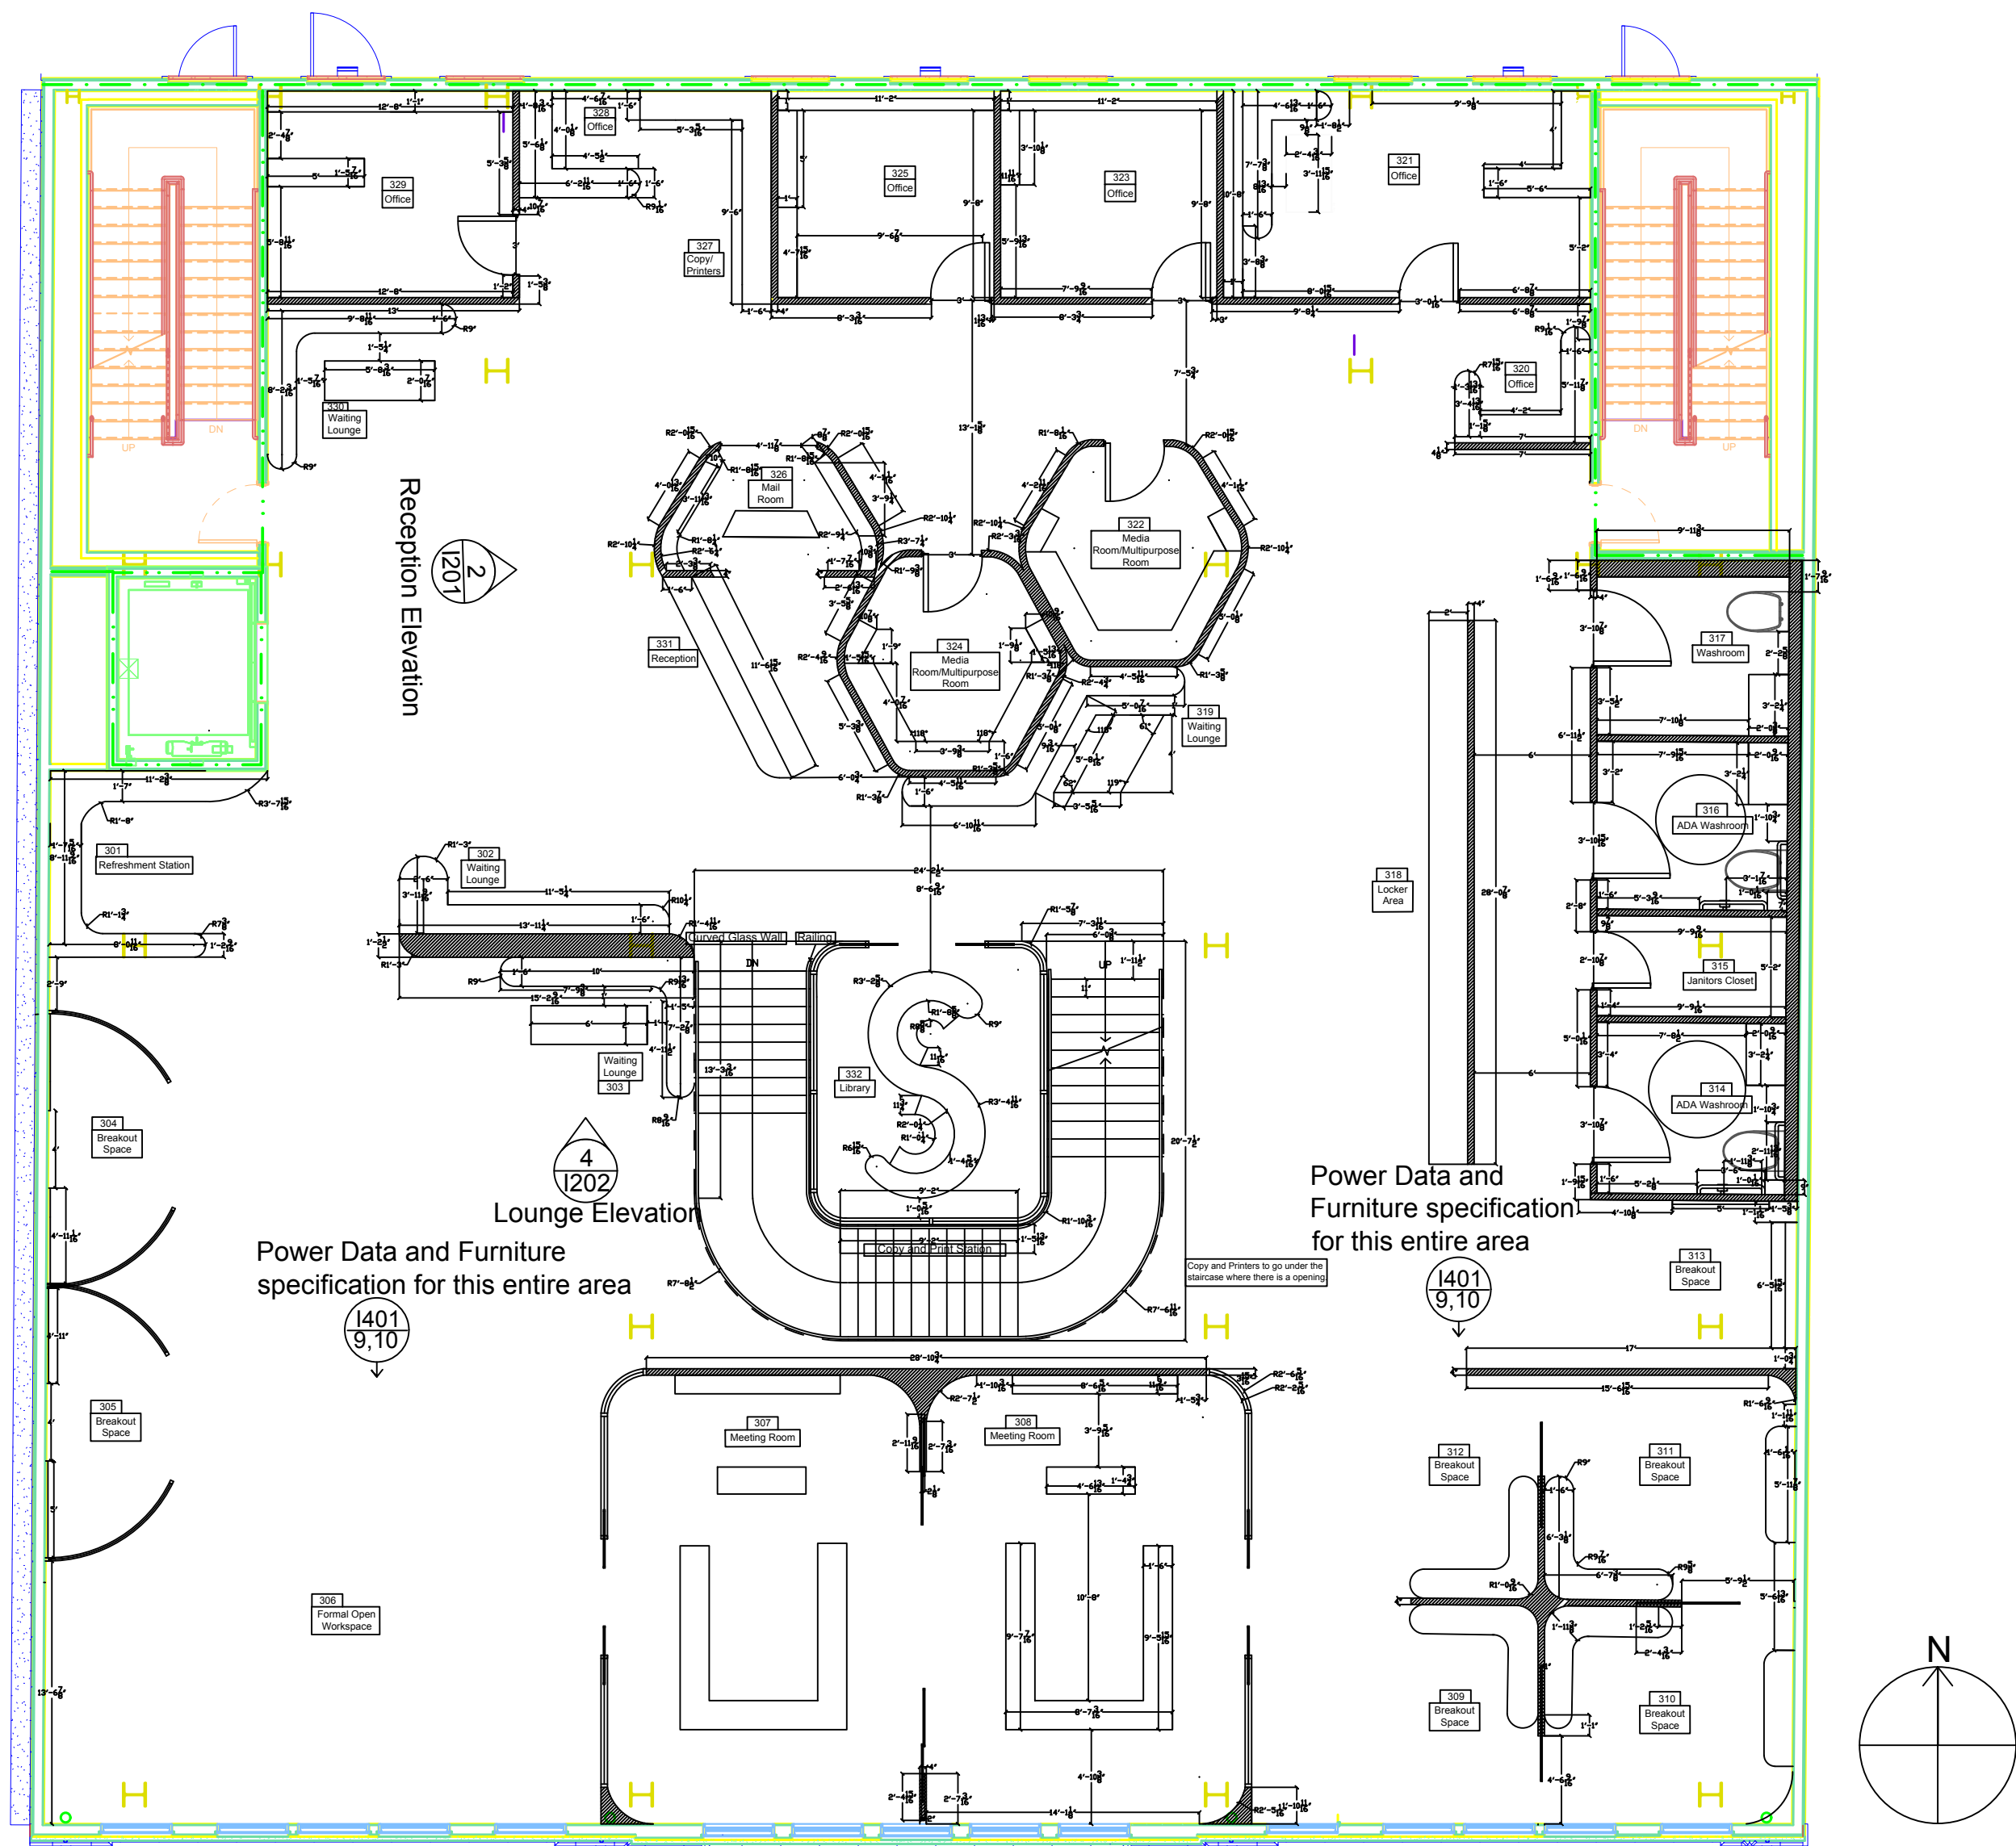Scale: 1/8" = 1'-0"



2. Third Floor Plan
Scale: 1/8" = 1'-0"



Vidhanshi Soni
<https://vidhanshi25soni.wixsite.com/vidhanshisoni>
Clark Hall, Savannah, Georgia
Job Date: 1st March, 2024

Vetster's Workspace

230-240 W Broughton Street, Savannah,
Georgia, 31401, United States

Revision


Checked by: Vidhanshi Soni

Floor Plan- Third Floor

A102


Tag	Manufacturer	Type	Notes
A	Armstrong World Industries	Seamless Acoustical Ceiling System	0.80 NRC
B	Armstrong World Industries	Ultima Health Zone	0.80 NRC
C	Turf Design	Freeform: Acoustic Ceiling Baffle	NRC 0.55 – 0.95

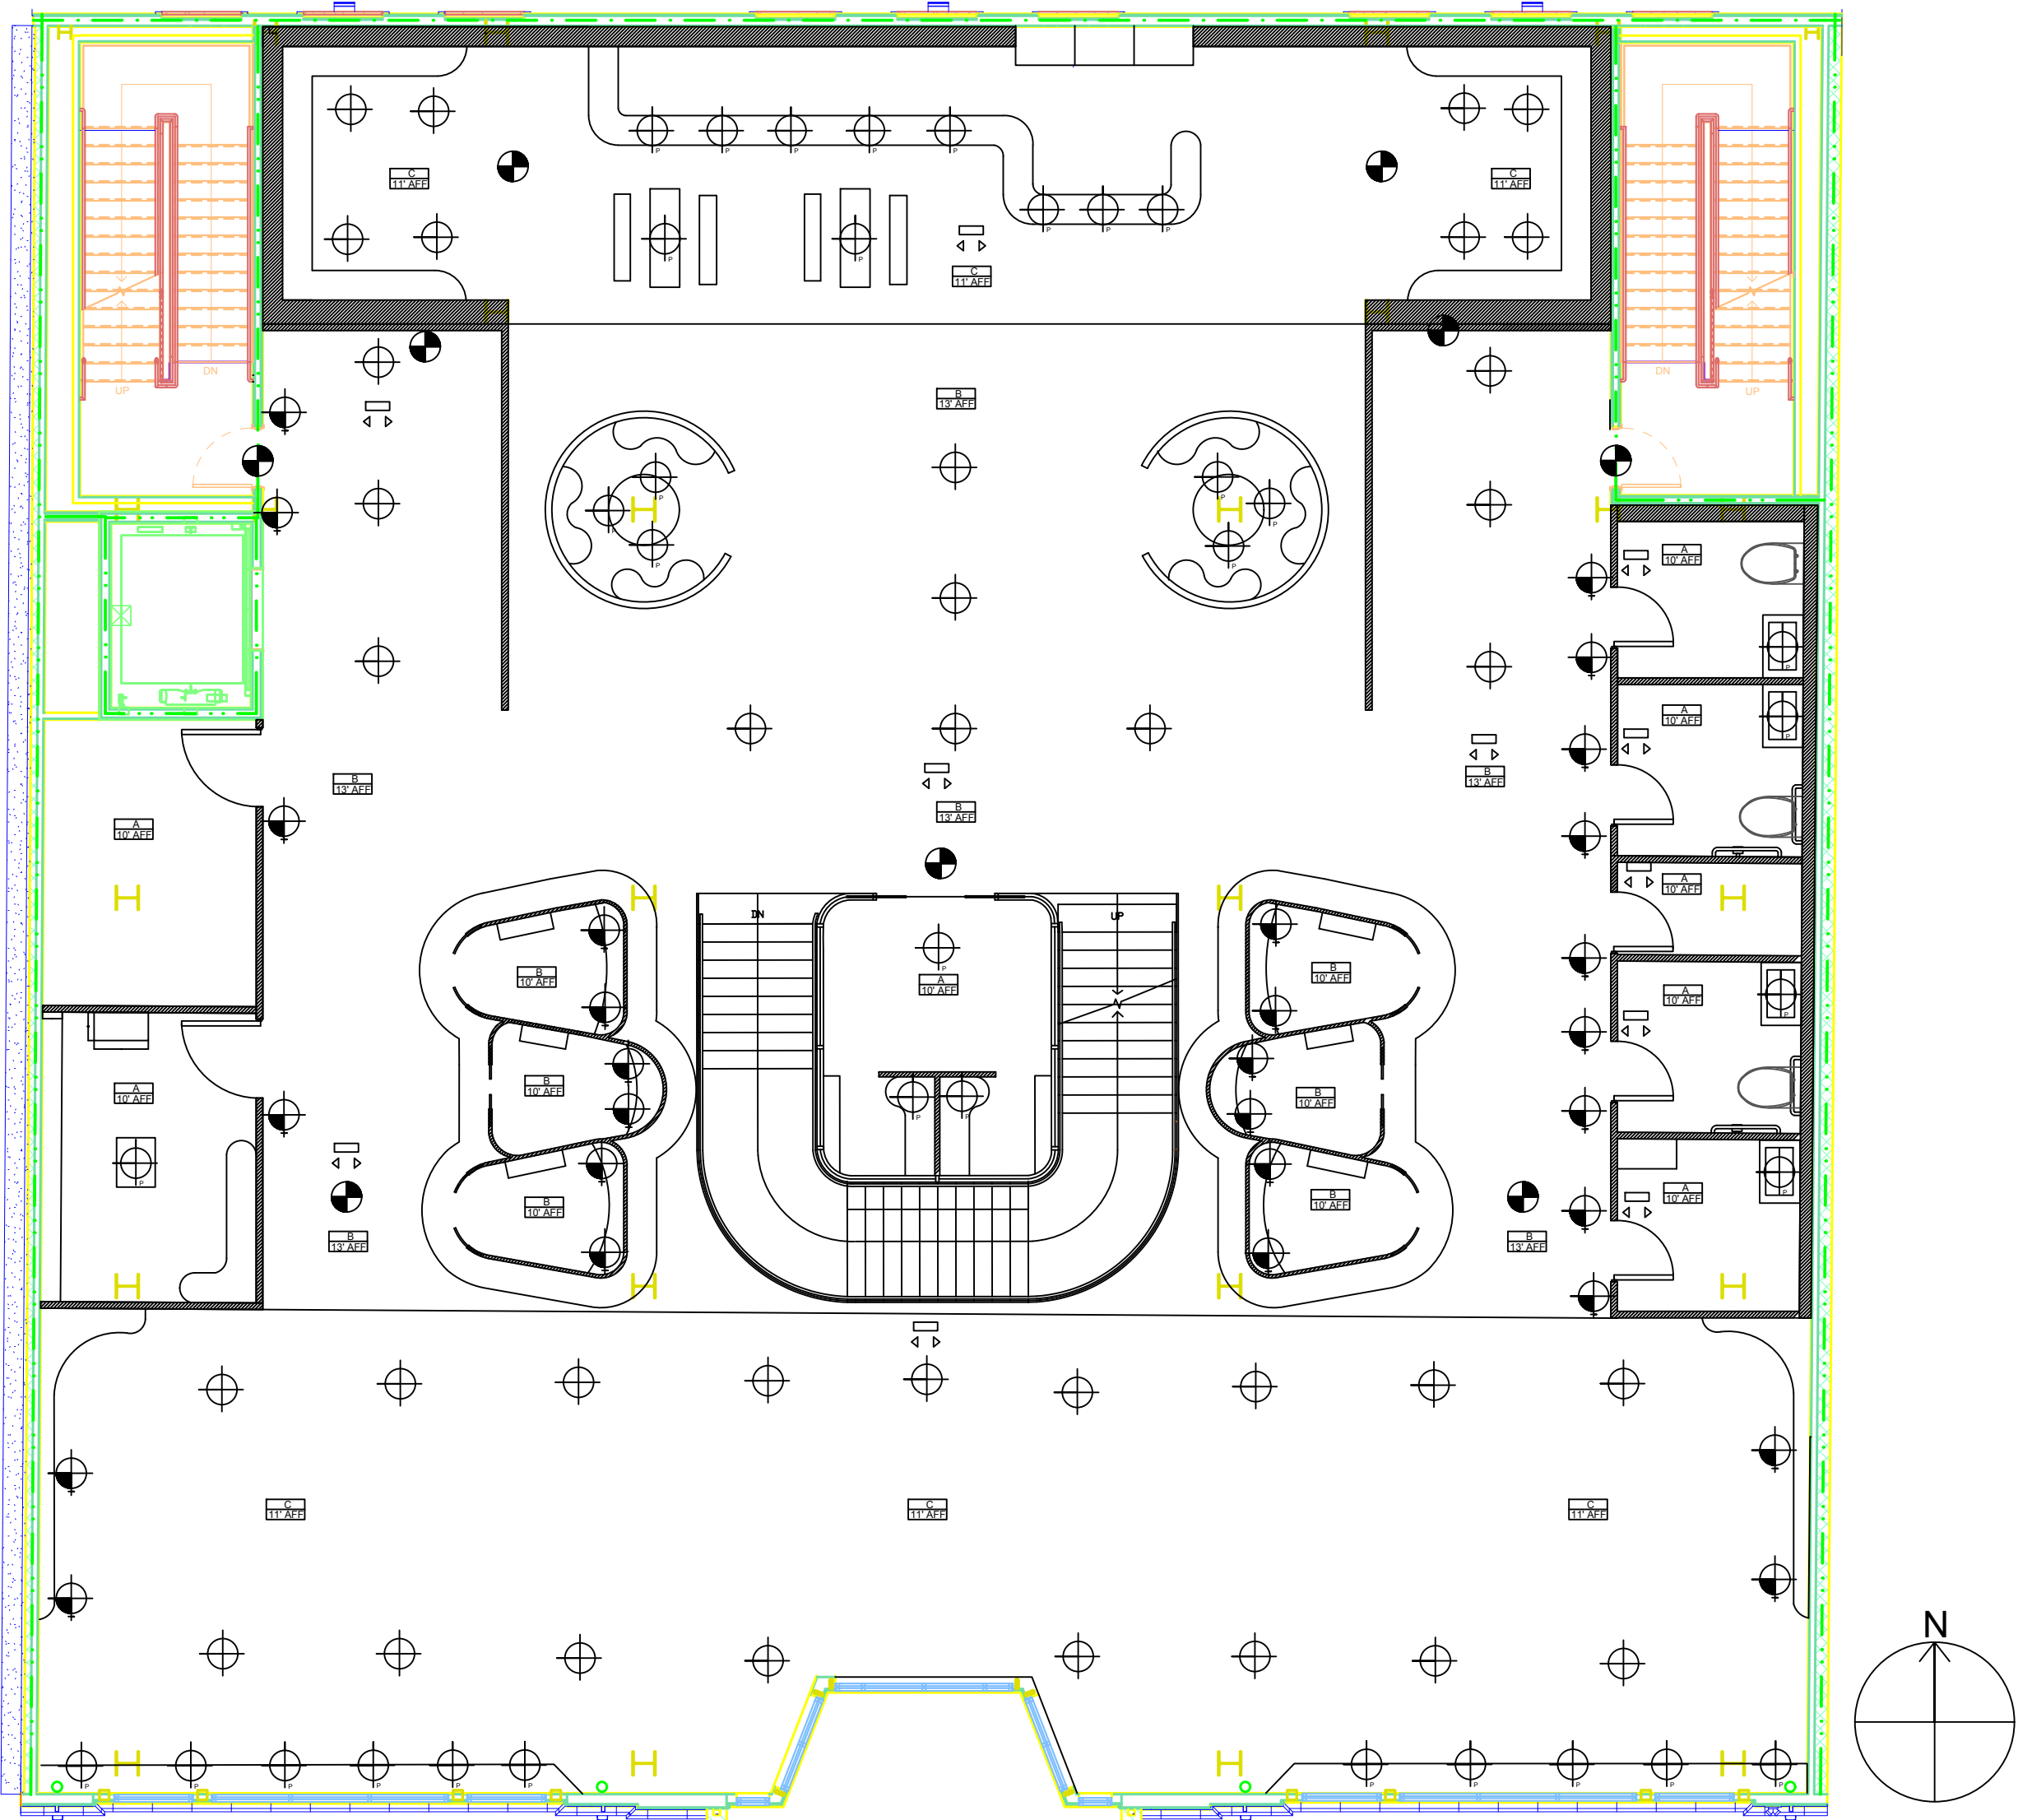Notes
Scale: 1/8" = 1'-0"
AFF: Above Finished Floor
⊕ Ceiling mounted Pendant
⊕ Ceiling mounted light
● Wall mounted light
⬤ Exit Light
⬢ Emergency Light



3. Second Floor Reflected ceiling plan

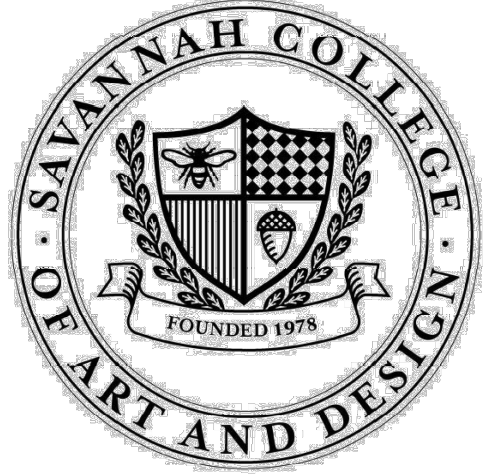Scale: 1/8" = 1'-0"




Vidhanshi Soni
<https://vidhanshi25soni.wixsite.com/vidhanshisoni>
 Clark Hall, Savannah, Georgia
 Job Date: 1st March, 2024

Vetster's Workspace
 230-240 W Broughton Street, Savannah,
 Georgia, 31401, United States





Revision

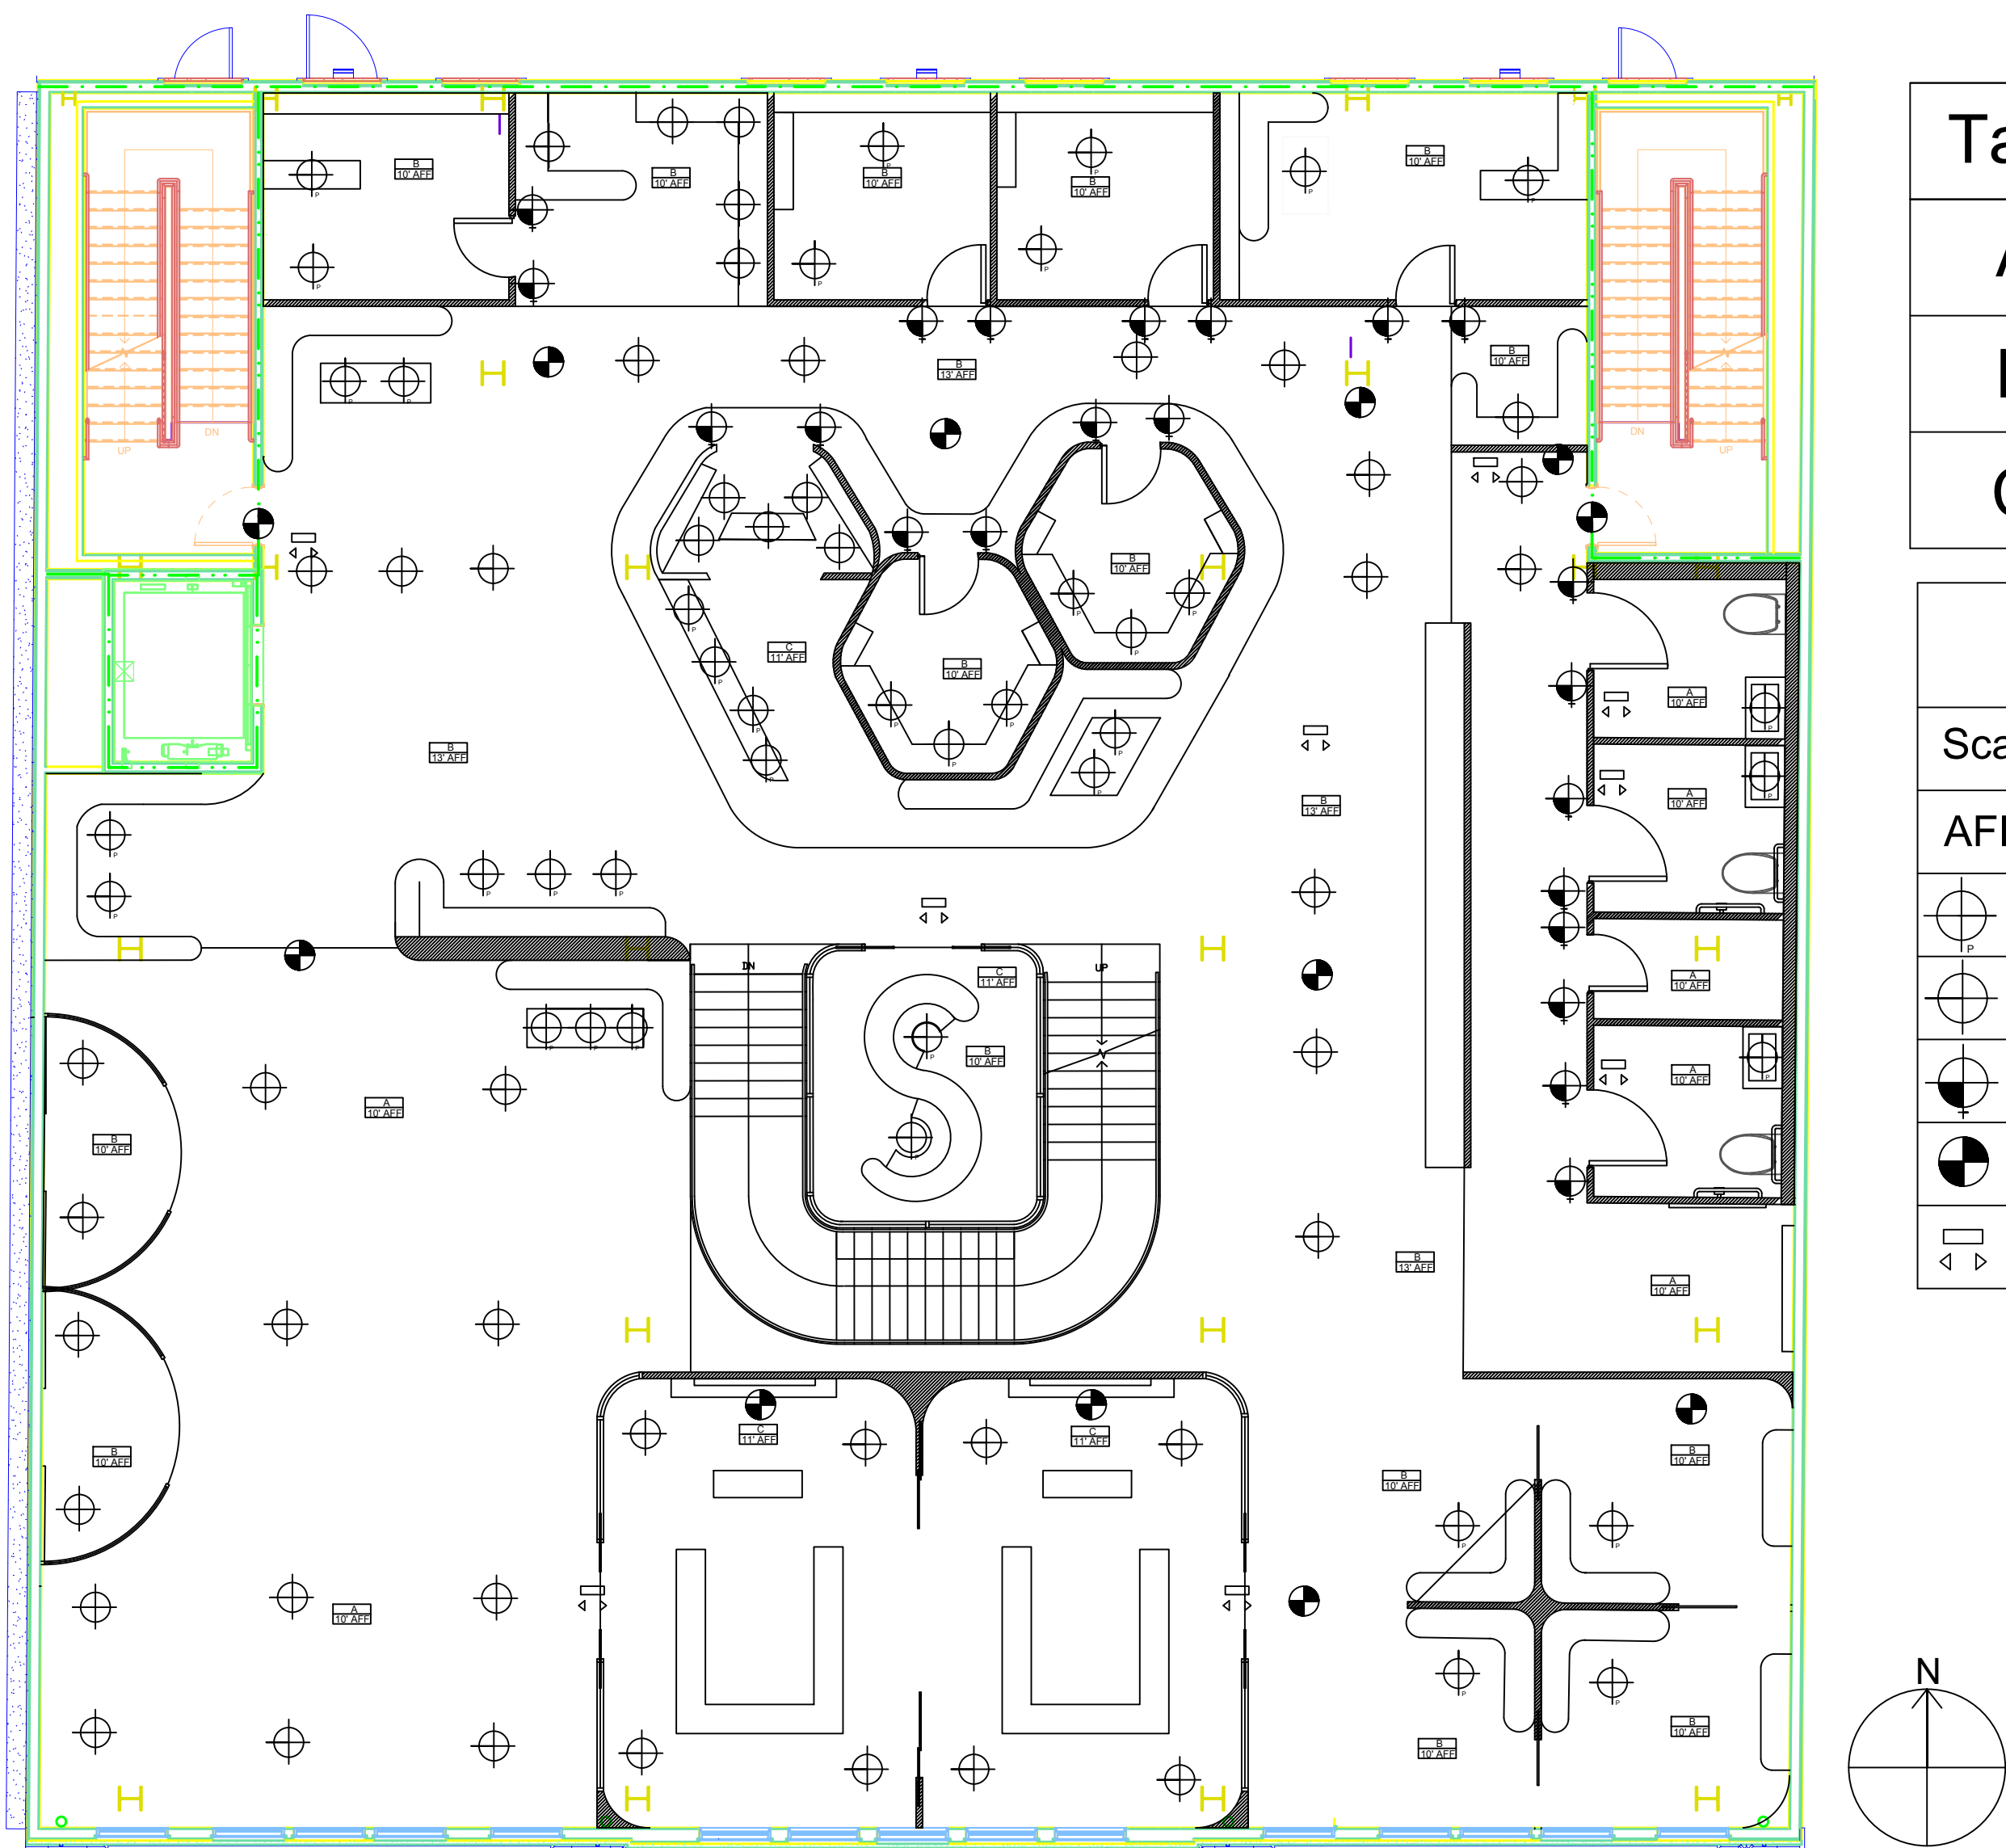
Checked by: Vidhanshi Soni
 Reflected ceiling plan
 A103



4. Third Floor Reflected ceiling plan
Scale: 1/8" = 1'-0"

Tag	Manufacturer	Type	Notes
A	Armstrong World Industries	Seamless Acoustical Ceiling System	0.80 NRC
B	Armstrong World Industries	Ultima Health Zone	0.80 NRC
C	Turf Design	Freeform: Acoustic Ceiling Baffle	NRC 0.55 – 0.95

    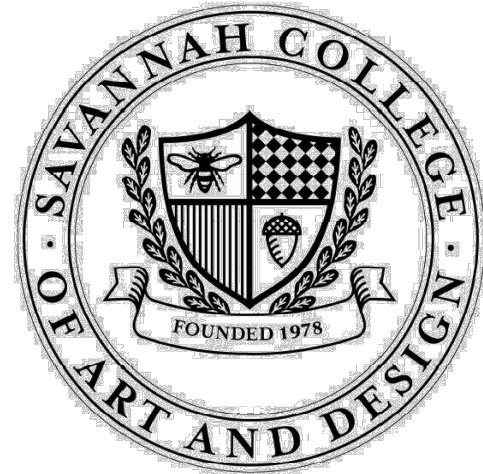Notes
Scale: 1/8" = 1'-0"
AFF: Above Finished Floor
 Ceiling mounted Pendant
 Ceiling mounted light
 Wall mounted light
 Exit Light
 Emergency Light



Vidhanshi Soni
<https://vidhanshi25soni.wixsite.com/vidhanshisoni>
Clark Hall, Savannah, Georgia
Job Date: 1st March, 2024

Vetster's Workspace
230-240 W Broughton Street, Savannah,
Georgia, 31401, United States

Revision

Checked by: Vidhanshi Soni

Reflected Ceiling Plan

A104



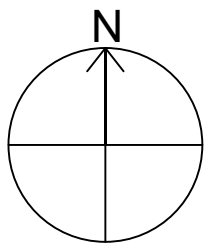
230-240 W Broughton Street, Savannah,
Georgia, 31401, United States

Revision


Checked by: Vidhanshi Soni

Second Floor Furniture Plan


1101



Scale: 1/8" = 1'-0"

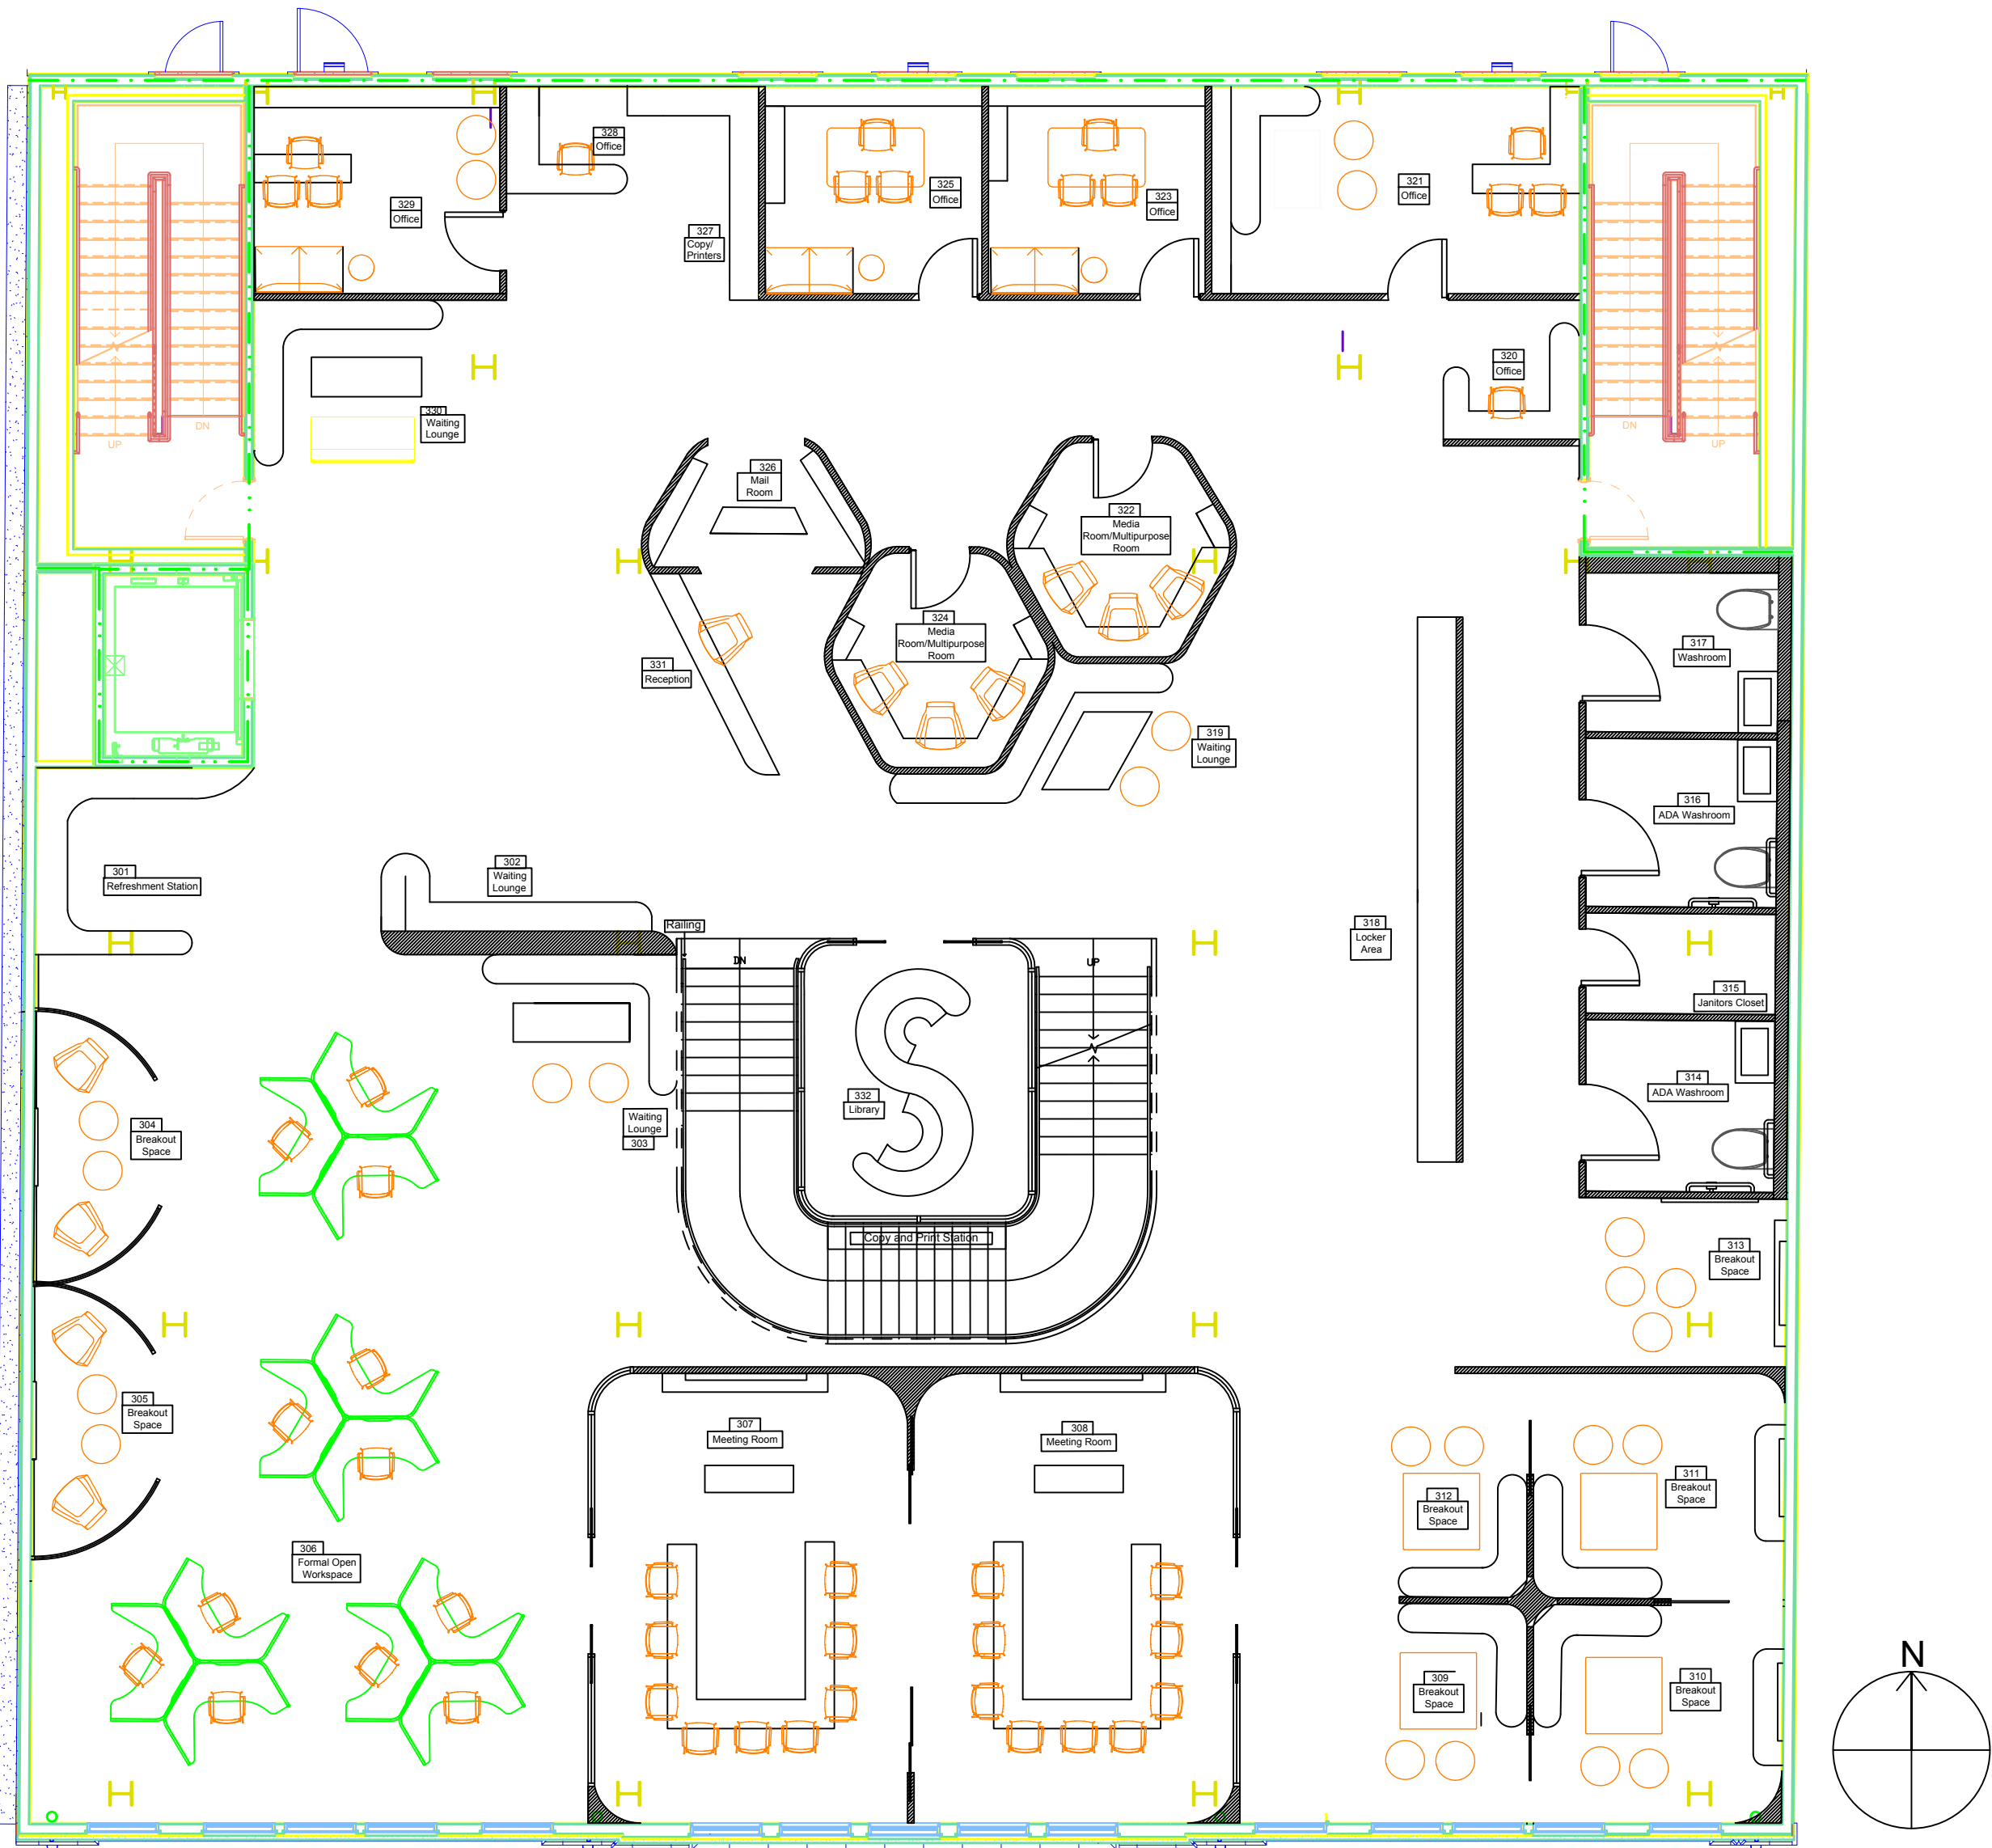

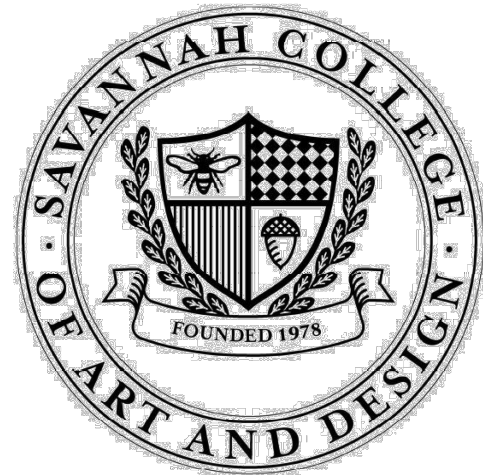6. Third Floor Furniture Plan
Scale: 1/8" = 1'-0"



Vidhanshi Soni
https://vidhanshi25soni.wixsite.com/vidhanshisoni
Clark Hall, Savannah, Georgia
Job Date: 1st March, 2024

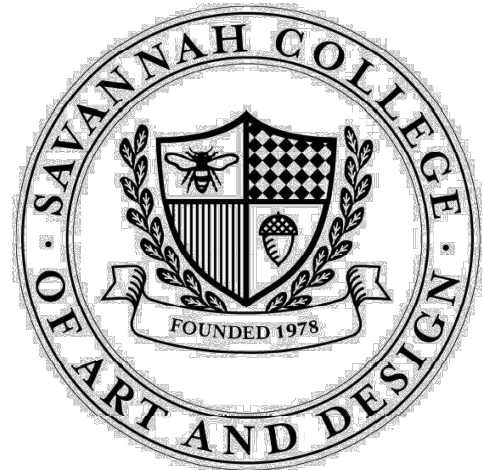
Vetster's Workspace

230-240 W Broughton Street, Savannah,
Georgia, 31401, United States

Revision

Checked by: Vidhanshi Soni
Third Floor Furniture Plan

I102



Vidhanshi Soni
https://vidhanshi25soni.wixsite.com/vidhanshisoni
Clark Hall, Savannah, Georgia
Job Date: 1st March, 2024

Vetster's Workspace

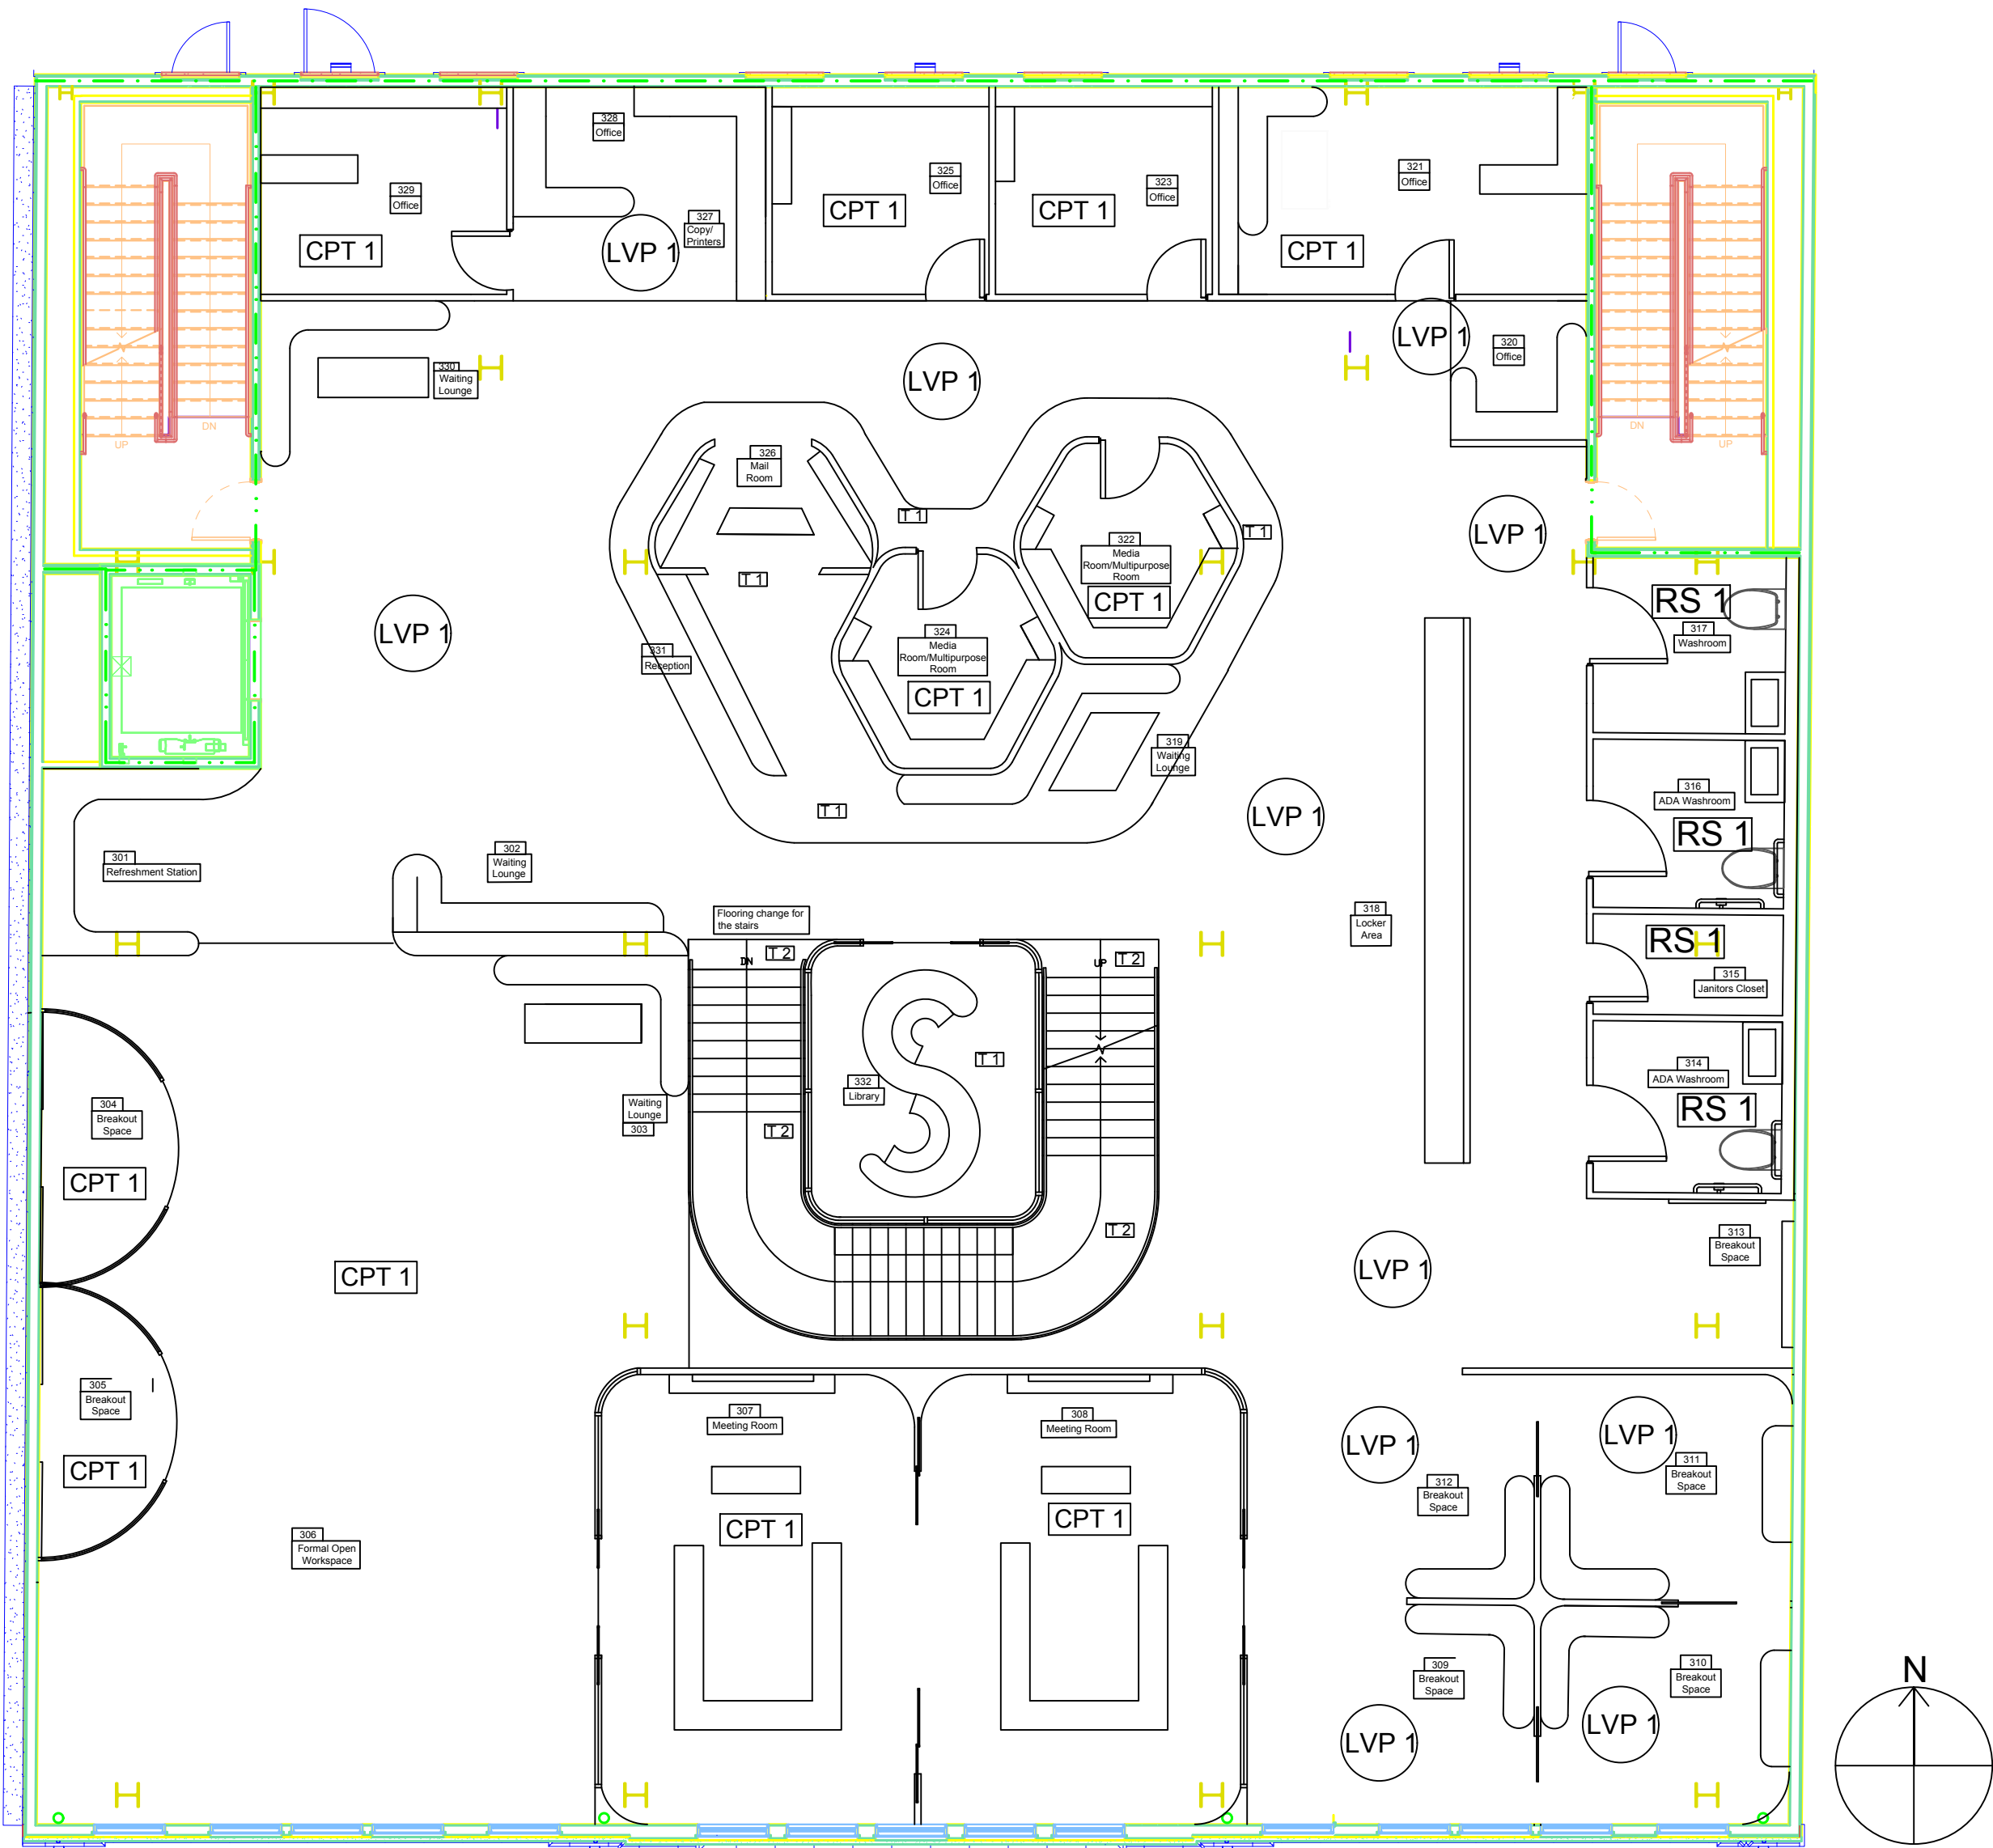
230-240 W Broughton Street, Savannah,
Georgia, 31401, United States

Revision

Checked by: Vidhanshi Soni

Floor Finish Plan- Third Floor

I104




8. Third Floor- Floor Finish Plan
Scale: 1/8" = 1'-0"



Tag	Manufacturer	Name	Color	Size	Installation Instructions	Notes
LVP 1	Armstrong Flooring	Mixer 2 Pina Colada: ST510	Pina Colada	6 in. x 36 in. x 0.1 in.	Ashler	Extends under room no. 320 as well
RS 1	Mannington Commercial	Attune	Suber Bergamot	5'10"		
T 1	Mohawk Group	Taking Root	Reshape	18"X36"		
CPT 1	Patcraft	Composed Layer	GINGER 00100	18"X36"		
T 2	Porcelanosa	Focus White Gold	White	11"X11"		

Notes
Scale: 1/8" = 1'-0"
LVP: Luxury Vinyl Plank
RS: Resistant Sheet
T: Tile
CPT: Carpet

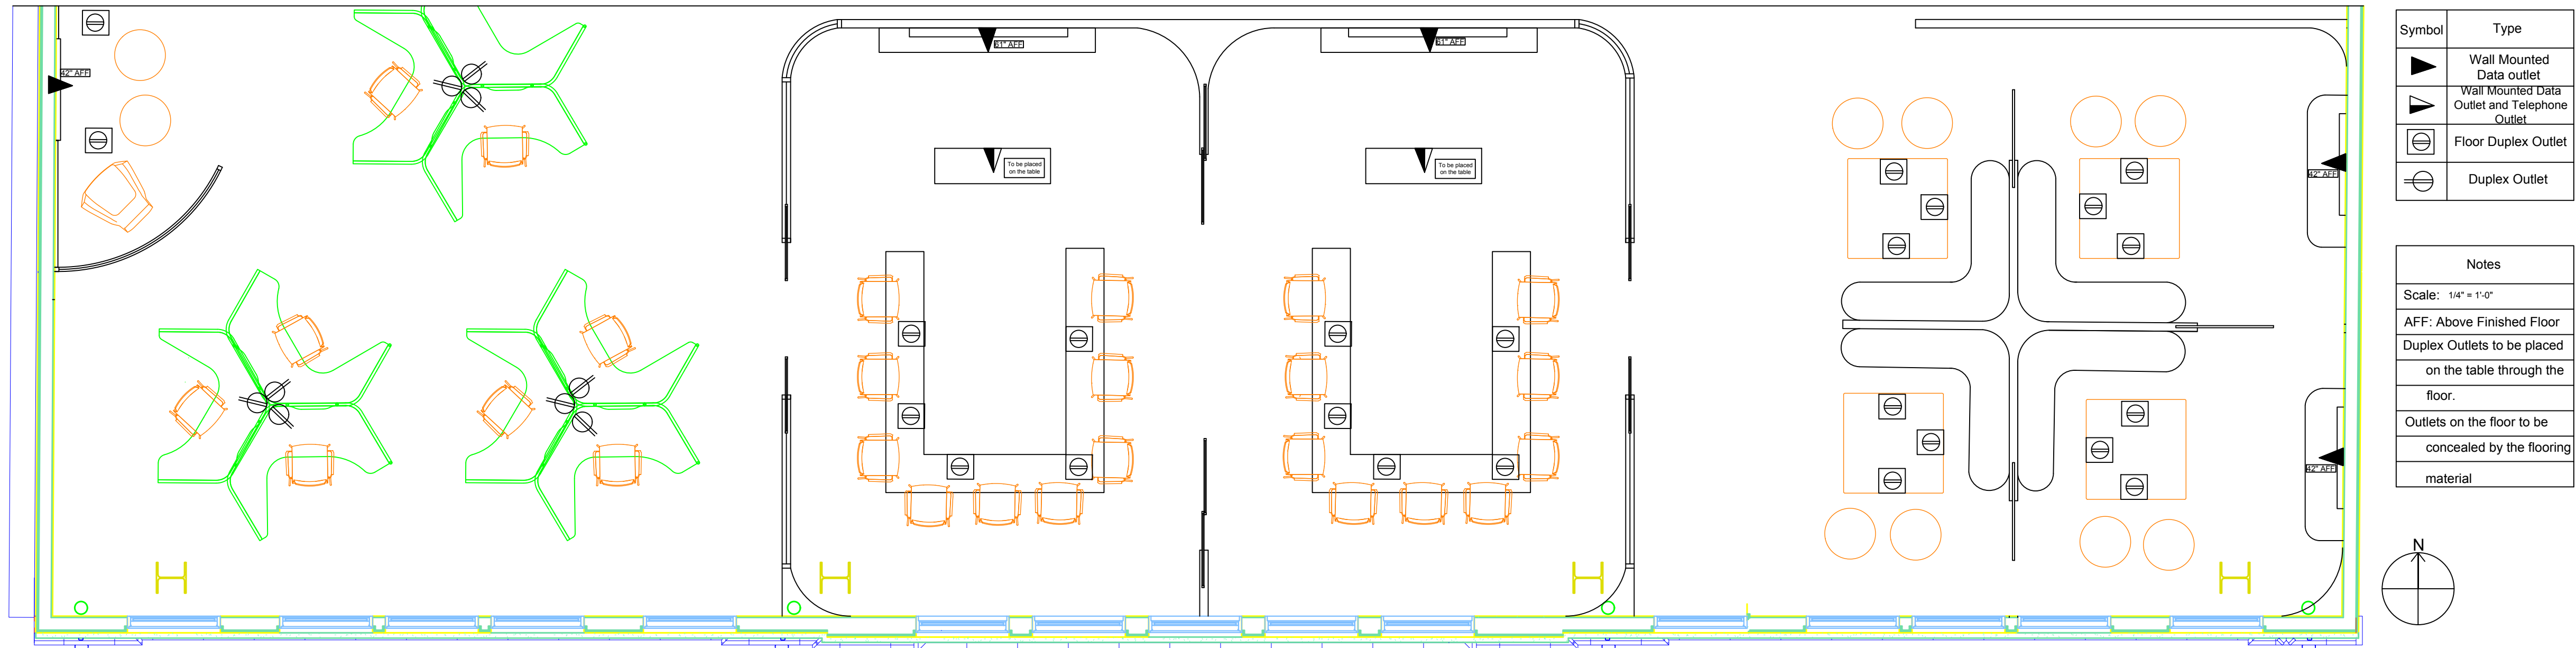9. Third Floor Power and Data plan (Large Scale)
Scale: 1/4" = 1'-0"



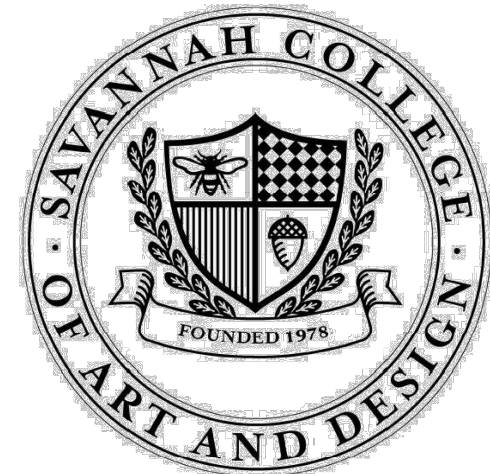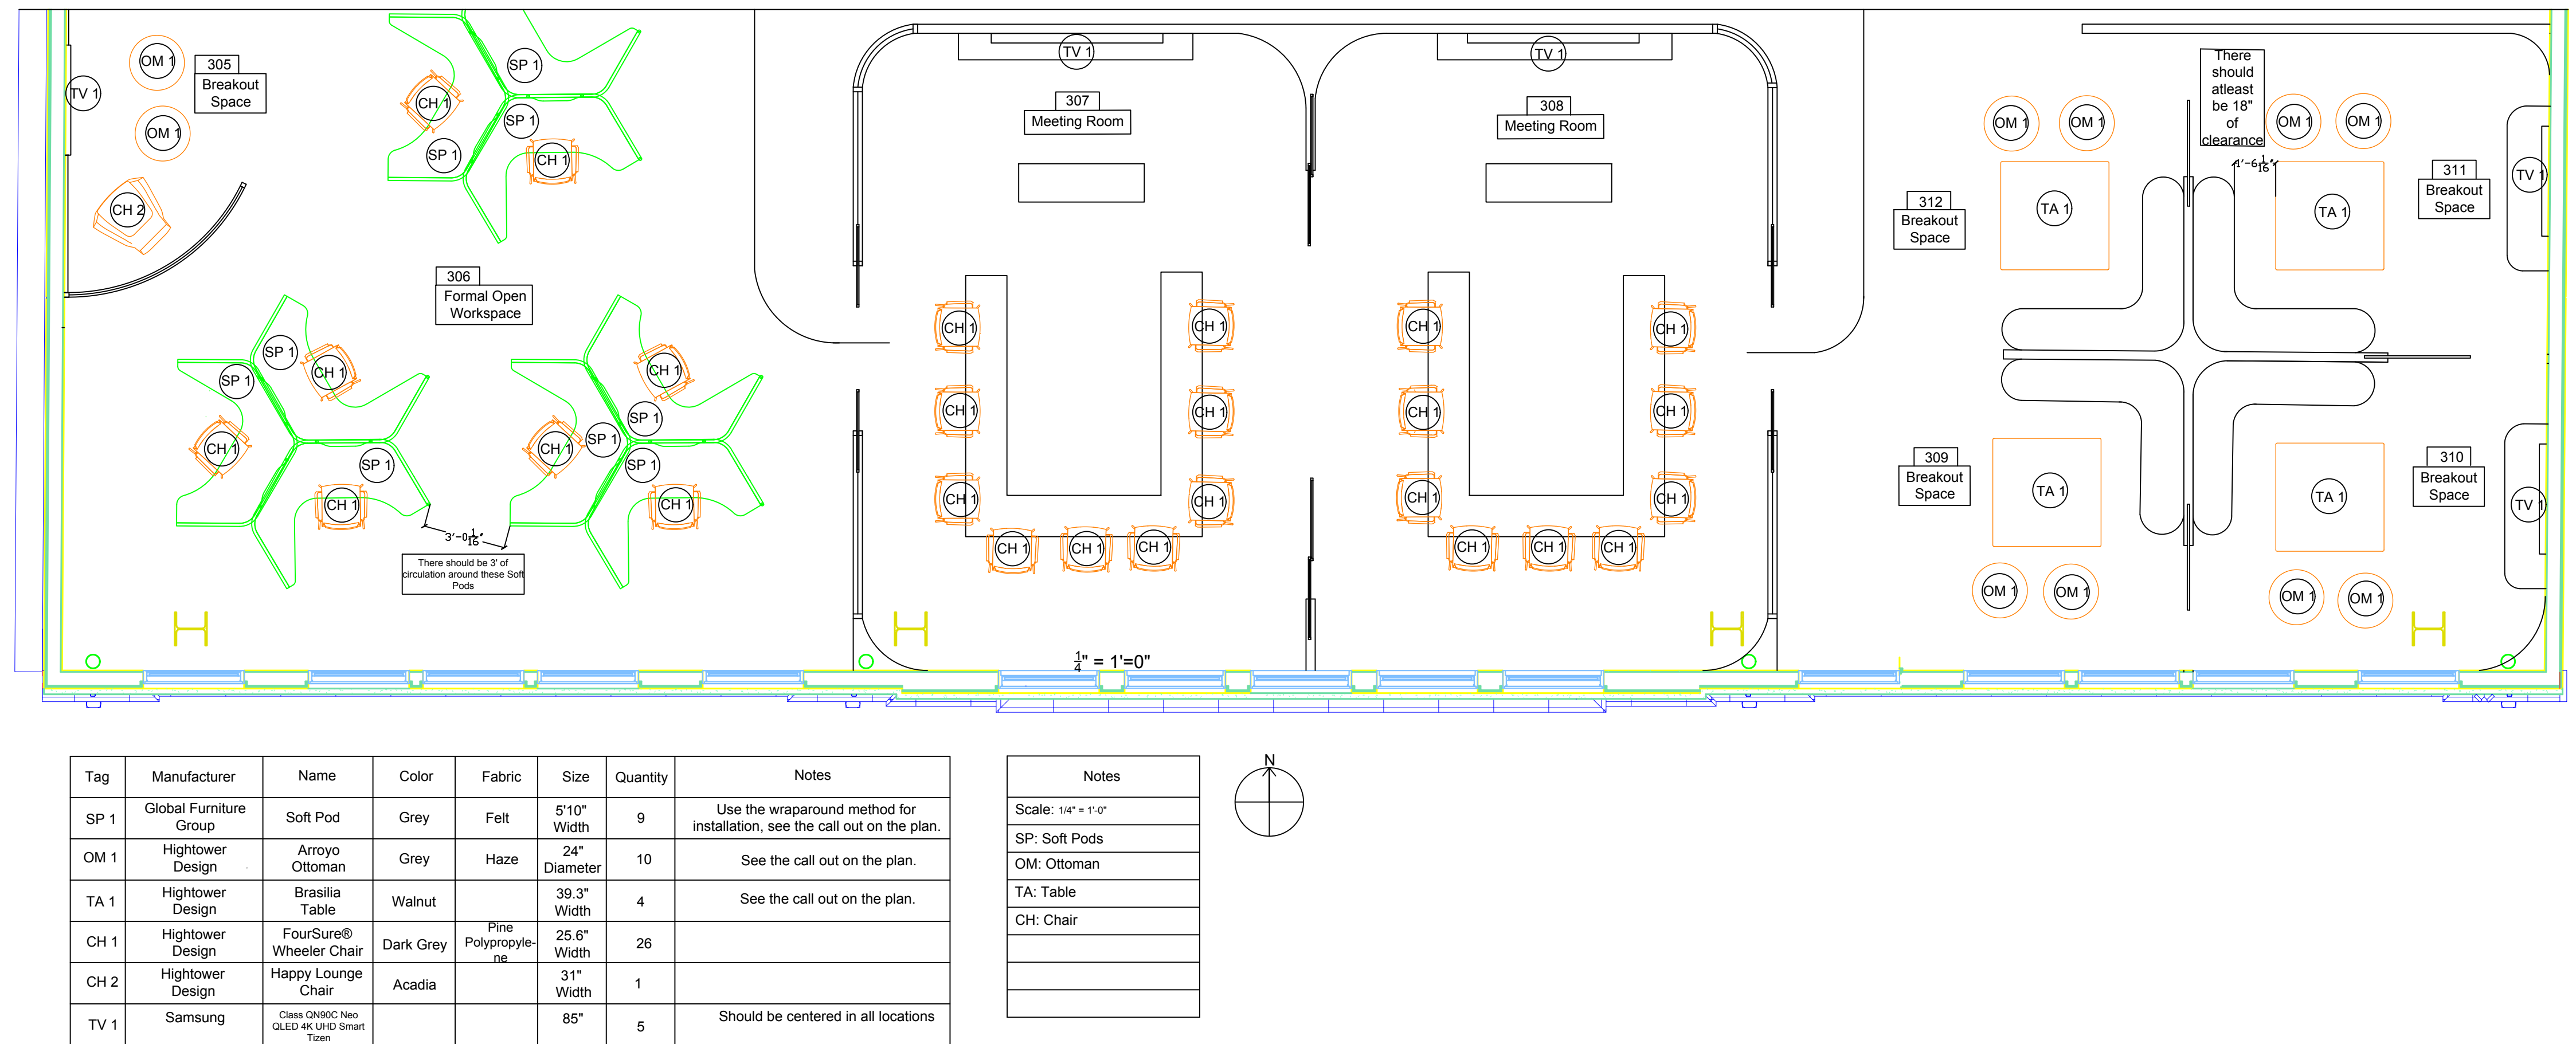10. Third Floor Furniture Specification plan (Large Scale)
Scale: 1/4" = 1'-0"



Vidhanshi Soni
<https://vidhanshi25soni.wixsite.com/vidhanshi25soni>
Clark Hall, Savannah, Georgia
Job Date- 1st March, 2024

Vetster's Workspace

230-240 W Broughton Street, Savannah,
Georgia, 31401, United States

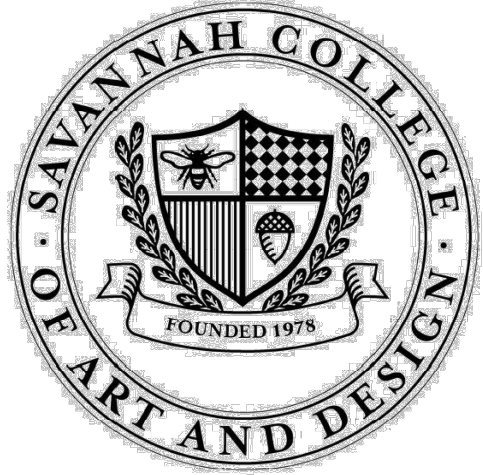
Revision

Checked by: Vidhanshi Soni

Power data and Furniture
Specification- Large scale

I401





Vidhanshi Soni
https://vidhanshi25soni.wixsite.com/vidhanshisoni
Clark Hall, Savannah, Georgia
Job Date- 1st March, 2024

Vetster's Workspace
230-240 W Broughton Street, Savannah,
Georgia, 31401, United States

Revision

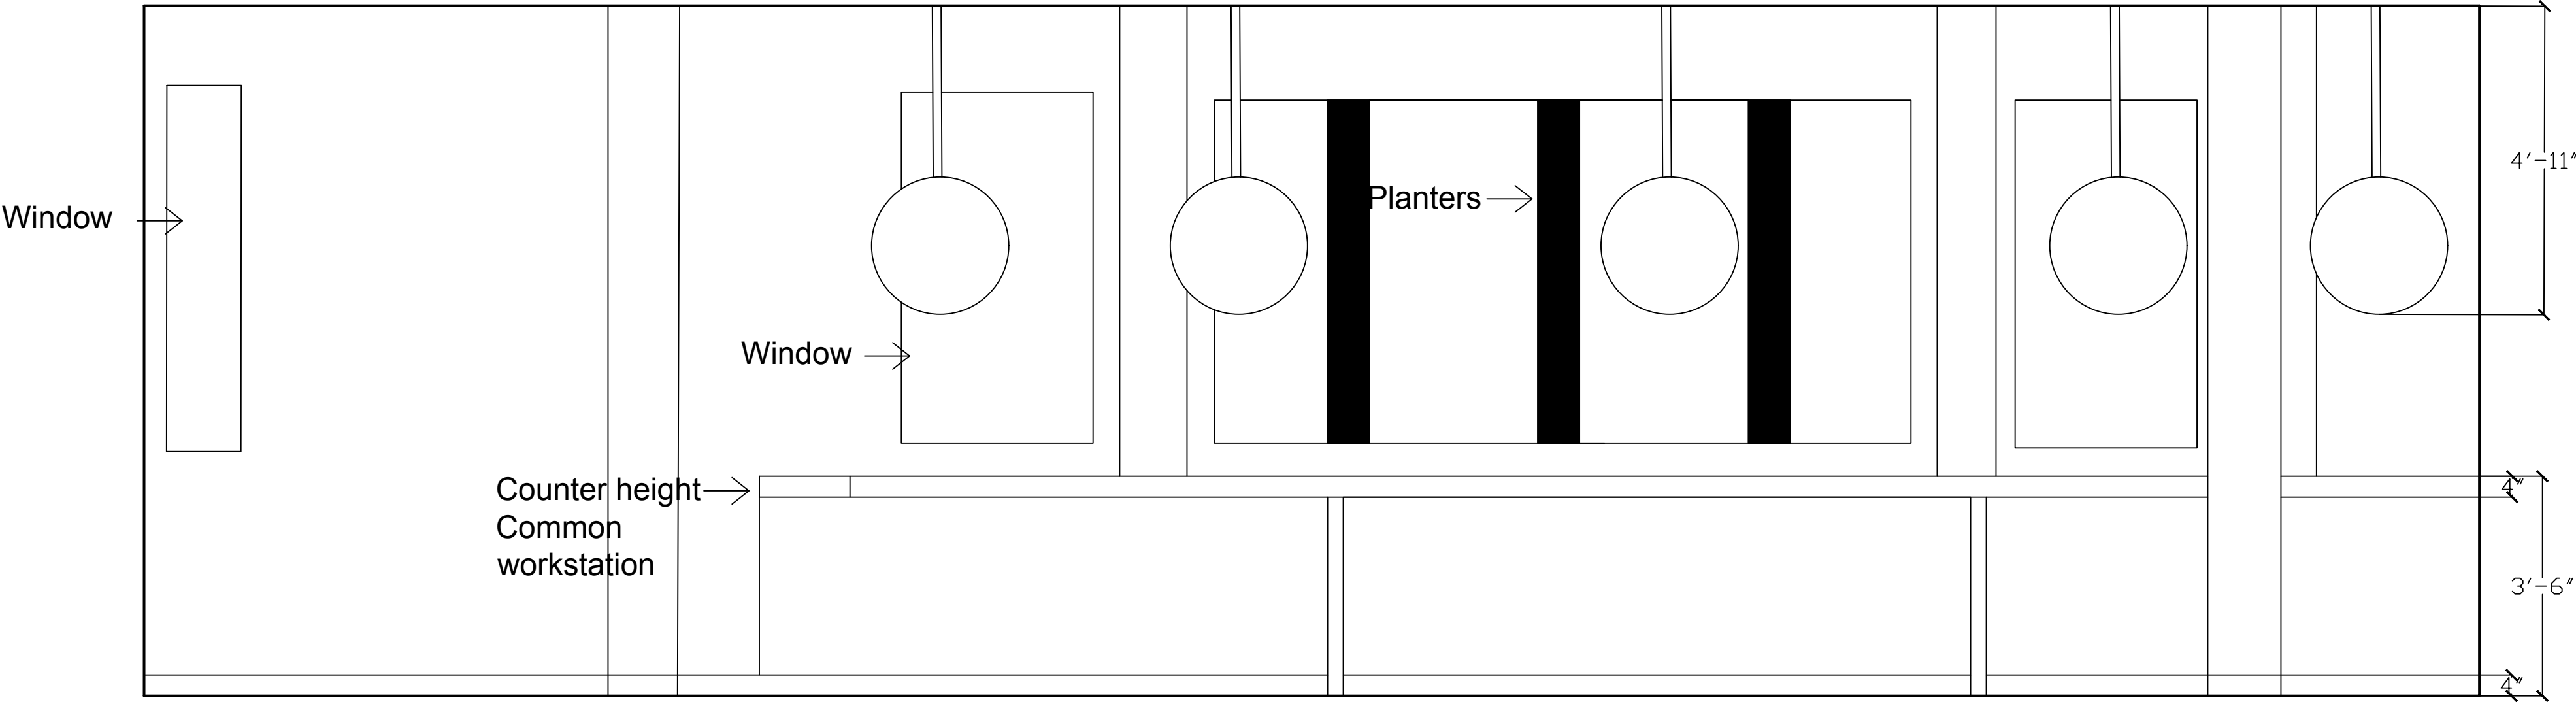
Checked by: Vidhanshi Soni

Elevations

I202

3. Common counter height workstation- Second Floor

Scale: 1/2" = 1'-0"



4. Waiting Lounge- Third Floor

Scale: 1/2" = 1'-0"

